


This drawing and all contents of it are the property of Hart Design Group, PLLC. Prices are to be returned to Hart Design Group, PLLC upon completion of the use for which they were issued. The reproduction, copying or other use of this drawing without the written consent of Hart Design Group, PLLC is prohibited and any infringement will be subject to legal action.

SUNDERLAND ENGINEERING
CONSULTING ENGINEERS
3328 CLARENDON RD. DURHAM NC 27705
(919) 477-7001, 477-9028 fax
www.sunderlandeng.com

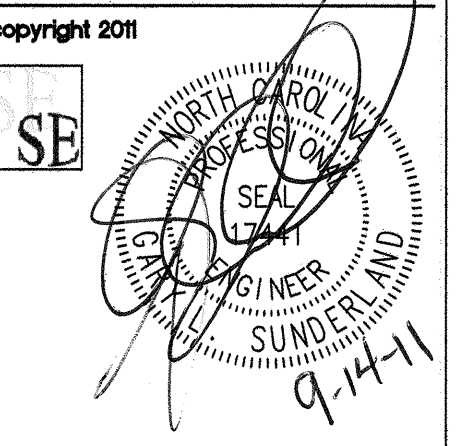

APEX SCHOOL OF THEOLOGY
1704 TW ALEXANDER,
DURHAM NORTH CAROLINA

PRINCIPAL IN CHARGE
GLS
PROJECT MANAGER
GLS
DRAWN BY
ZLT/IMR/ERC


NO.	ISSUED FOR PERMIT	DATE
1	ISSUED FOR PERMIT	08/28/11
2	ISSUED FOR PERMIT	09/13/11

REVISIONS	

SHEET TITLE	

PROJECT NO.	
HDG201009	SE 21115
ISSUE DATE	
09/13/11	E-3
	3 of 3

APEX SCHOOL OF THEOLOGY 09/13/11					
LIGHTING FIXTURE SCHEDULE					
TYPE	MANUFACTURER	CATALOG NUMBER	LAMPS	DESCRIPTION	VOLT WATT
A	LITHONIA	2GT8332A12120GEB10IS	3- 32W T8	2' X 4' FLUORESCENT RECESSED TROFFER MAIN AREAS	120 96
B	GOTHAM	CG10 1/28DTT6AR BLACK	2- 26W DTT	DIMMABLE COMPACT FLUORESCENT PENDANT CYLINDER-VERIFY DROP MULTIPURPOSE	120 62
C	LITHONIA	C132MVOLTGEB10ISAL	1- 32W T8	4' ALL-PURPOSE FLUORESCENT STRIP ELECT., JANITORS, DATA, MECHANICAL ROOM	120 32
D	LITHONIA	VW117MVOLTAL	1- 17W T8	2' WRAPAROUND LIGHT PRESIDENTS CLOSET	120 17
E1	LITHONIA	EDG1GEL	LED	EDGE-LIT SINGLE-FACE EXT	120 5
EM	LITHONIA QUANTUM	ELAWMR24 K605	2- 6W KRYPTON	INTERIOR EMERGENCY LIGHT WITH 90 MINUTE BATTERY BACK-UP	120 12
ER	LITHONIA QUANTUM	ELAMR24K0606	1-6W MR24	EXTERIOR EMERGENCY EGRESS LIGHT WITH 90 MINUTE BATTERY BACK-UP	120 6
EX	LITHONIA QUANTUM	LHQM5W1R120/277HO (AT) LHQM5W1R120/277	2- 6W MR24 LED	EXIT / EMERGENCY COMBINATION LIGHT WITH 90 MINUTE BATTERY BACK-UP	120 15
F	LITHONIA LITEPUFF	1890RE	2- 17W T8	VANITY WALL BRACKET PRESIDENTS TOILET	120 34
G	LITHONIA	AFV25DT16WRMVOLT ADEZ DIMMING BALLAST	1- 26W DTT	DIMMABLE 6" COMPACT FLUORESCENT RECESSED DOWNLIGHT CONFERENCE	120 26
H	LITHONIA PEERLESS	LD6 412655 T8R8 GEB10 DCT WHITE	6- 32W T8	6" ROUND, 8' SUSPENDED UP/DOWN-VERIFY DROP LIBRARY	120 198
J	LITHONIA	SB232MVOLTGEB10IS	2- 32W T8	1' X 4' SURFACE FLUORESCENT WRAPAROUND FOOD PREP, ELEC	120 64
K	PEACHTREE	PCTK-6242DIM	3- 42W TT 2 UP/1 DN	DIMMABLE 9" UP/DOWNLIGHT FLUORESCENT CYLINDER LOBBY	120 126
K1	PEACHTREE	PCTK-6242	3- 42W TT 2 UP/1 DN	WET LOCATION 9" UP/DOWNLIGHT FLUORESCENT CYLINDER OUTSIDE LOBBY	120 126
L	LITHONIA	LF82/18DTT802MVOLT GEB10	2- 18W DTT	6" HORIZONTAL COMPACT FLUORESCENT DOWNLIGHT TOILETS, LOBBY	120 36
L1	LITHONIA	LF82/18DTT802MVOLT GEB10	2- 18W DTT	6" HORIZONTAL COMPACT FLUORESCENT DOWNLIGHT ENTRANCES	120 36
M	CON-TECH LIGHTING	LIR381T ODYSSEY FLEX TRACK CHOOSE PARTS	1-50W MR16G	MONORAIL W/ TRACK HEADS LIBRARY CEILING PANEL AREA	120 50/FT.
N	LITHONIA CERRA	CRW8 154THO 4FTR4 WHITE	1-54W T8HO	4' BAFFLE WALL MOUNTED FLUORESCENT LIGHT ATRIUM	120 54
P	MARK LIGHTING	SL4F 8MTG 2TBEBIS 120FAWHD	2-32W T8 2-60W MR16	RECESSED FLUORESCENT W/ DOWNLIGHTS MULTIPURPOSE ROOM	120 164

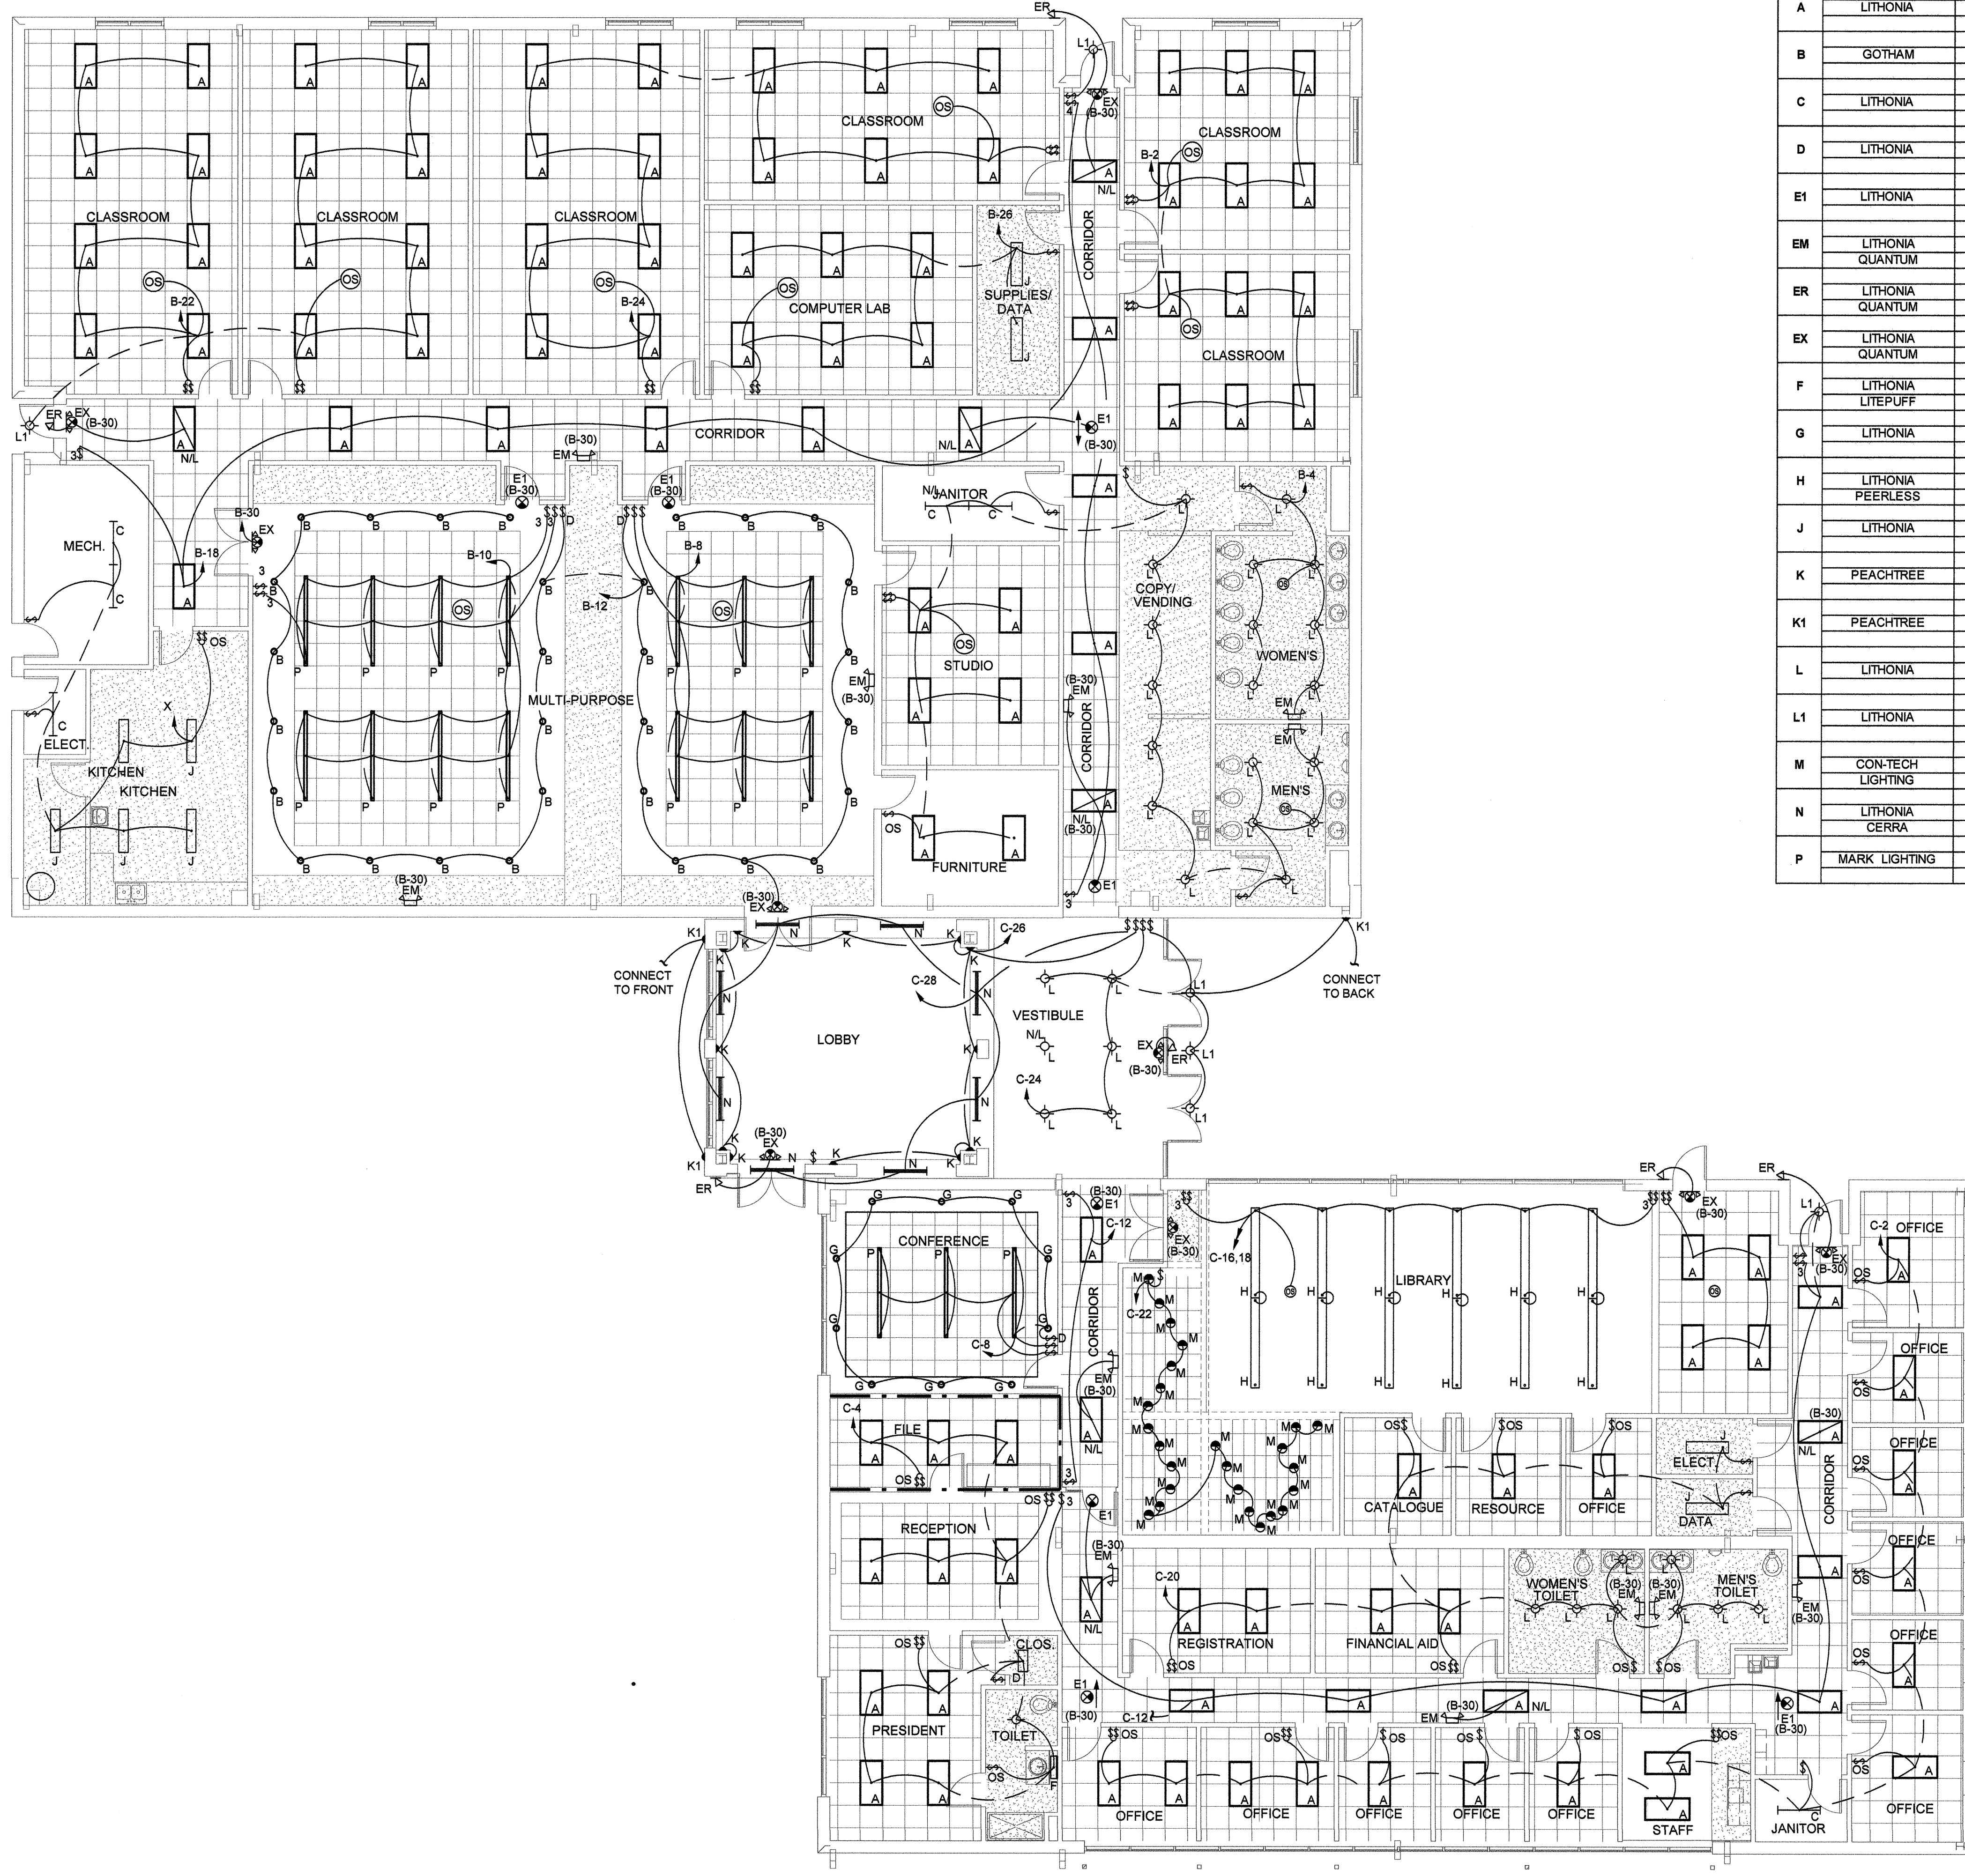

1 LIGHTING PLAN
E-3 SCALE: 1/8" = 1'-0"

RATED WALL LEGEND
1 HR RATED
CEILING IS NOT RATED

LIGHTING LEGEND	
SYMBOL	DESCRIPTION
[Symbol A]	2' X 4' FLUORESCENT RECESSED LIGHT
[Symbol B]	2' X 4' UNSWITCHED FLUORESCENT RECESSED NIGHT LIGHT
[Symbol C]	COMPACT FLUORESCENT CYLINDER
[Symbol D]	4' FLUORESCENT STRIP LIGHT
[Symbol E]	2' SURFACE-MOUNTED WRAPAROUND LIGHT
[Symbol EX]	SINGLE FACE EXIT SIGN
[Symbol E1]	SINGLE FACE EXIT SIGN
[Symbol ER]	EXTERIOR EMERGENCY EGRESS LIGHT
[Symbol F]	VANITY LIGHT
[Symbol G]	6" DIMMABLE RECESSED DOWN LIGHT
[Symbol H]	SUSPENDED 4' FIXTURE
[Symbol J]	4' SURFACE-MOUNTED WRAPAROUND LIGHT
[Symbol K]	UP/DOWNLIGHT
[Symbol L]	6" RECESSED CAN LIGHT NL = UNSWITCHED NIGHT LIGHT
[Symbol L1]	6" EXTERIOR RECESSED CAN LIGHT
[Symbol M]	MINI-PENDANT ON MONORAIL
[Symbol N]	ANGULAR WALL LIGHT
[Symbol P]	RECESSED SLOT LIGHT
[Symbol OS]	CEILING-MOUNTED OCCUPANCY SENSOR
[Symbol FAN]	FAN FL = FANLIGHT
[Symbol S]	SWITCH D = DIMMABLE 3" DOUBLE POLE 4" TRIPPOLE
[Symbol IN]	INBOARD / OUTBOARD SWITCH OS = OCCUPANCY SENSOR