



APEX SCHOOL OF THEOLOGY
1704 TW ALEXANDER,
DURHAM NORTH CAROLINA


PRINCIPAL IN CHARGE GLS	
PROJECT MANAGER GLS	
DRAWN BY ZLT/IMR/ERC	
REVISIONS	
NO.	DATE
1	08/28/11
2	09/13/11
SHEET TITLE	
PROJECT NO. HDG201009 SE 21115	
ISSUE DATE	SHEET NUMBER
09/13/11	P-2 2 of 2

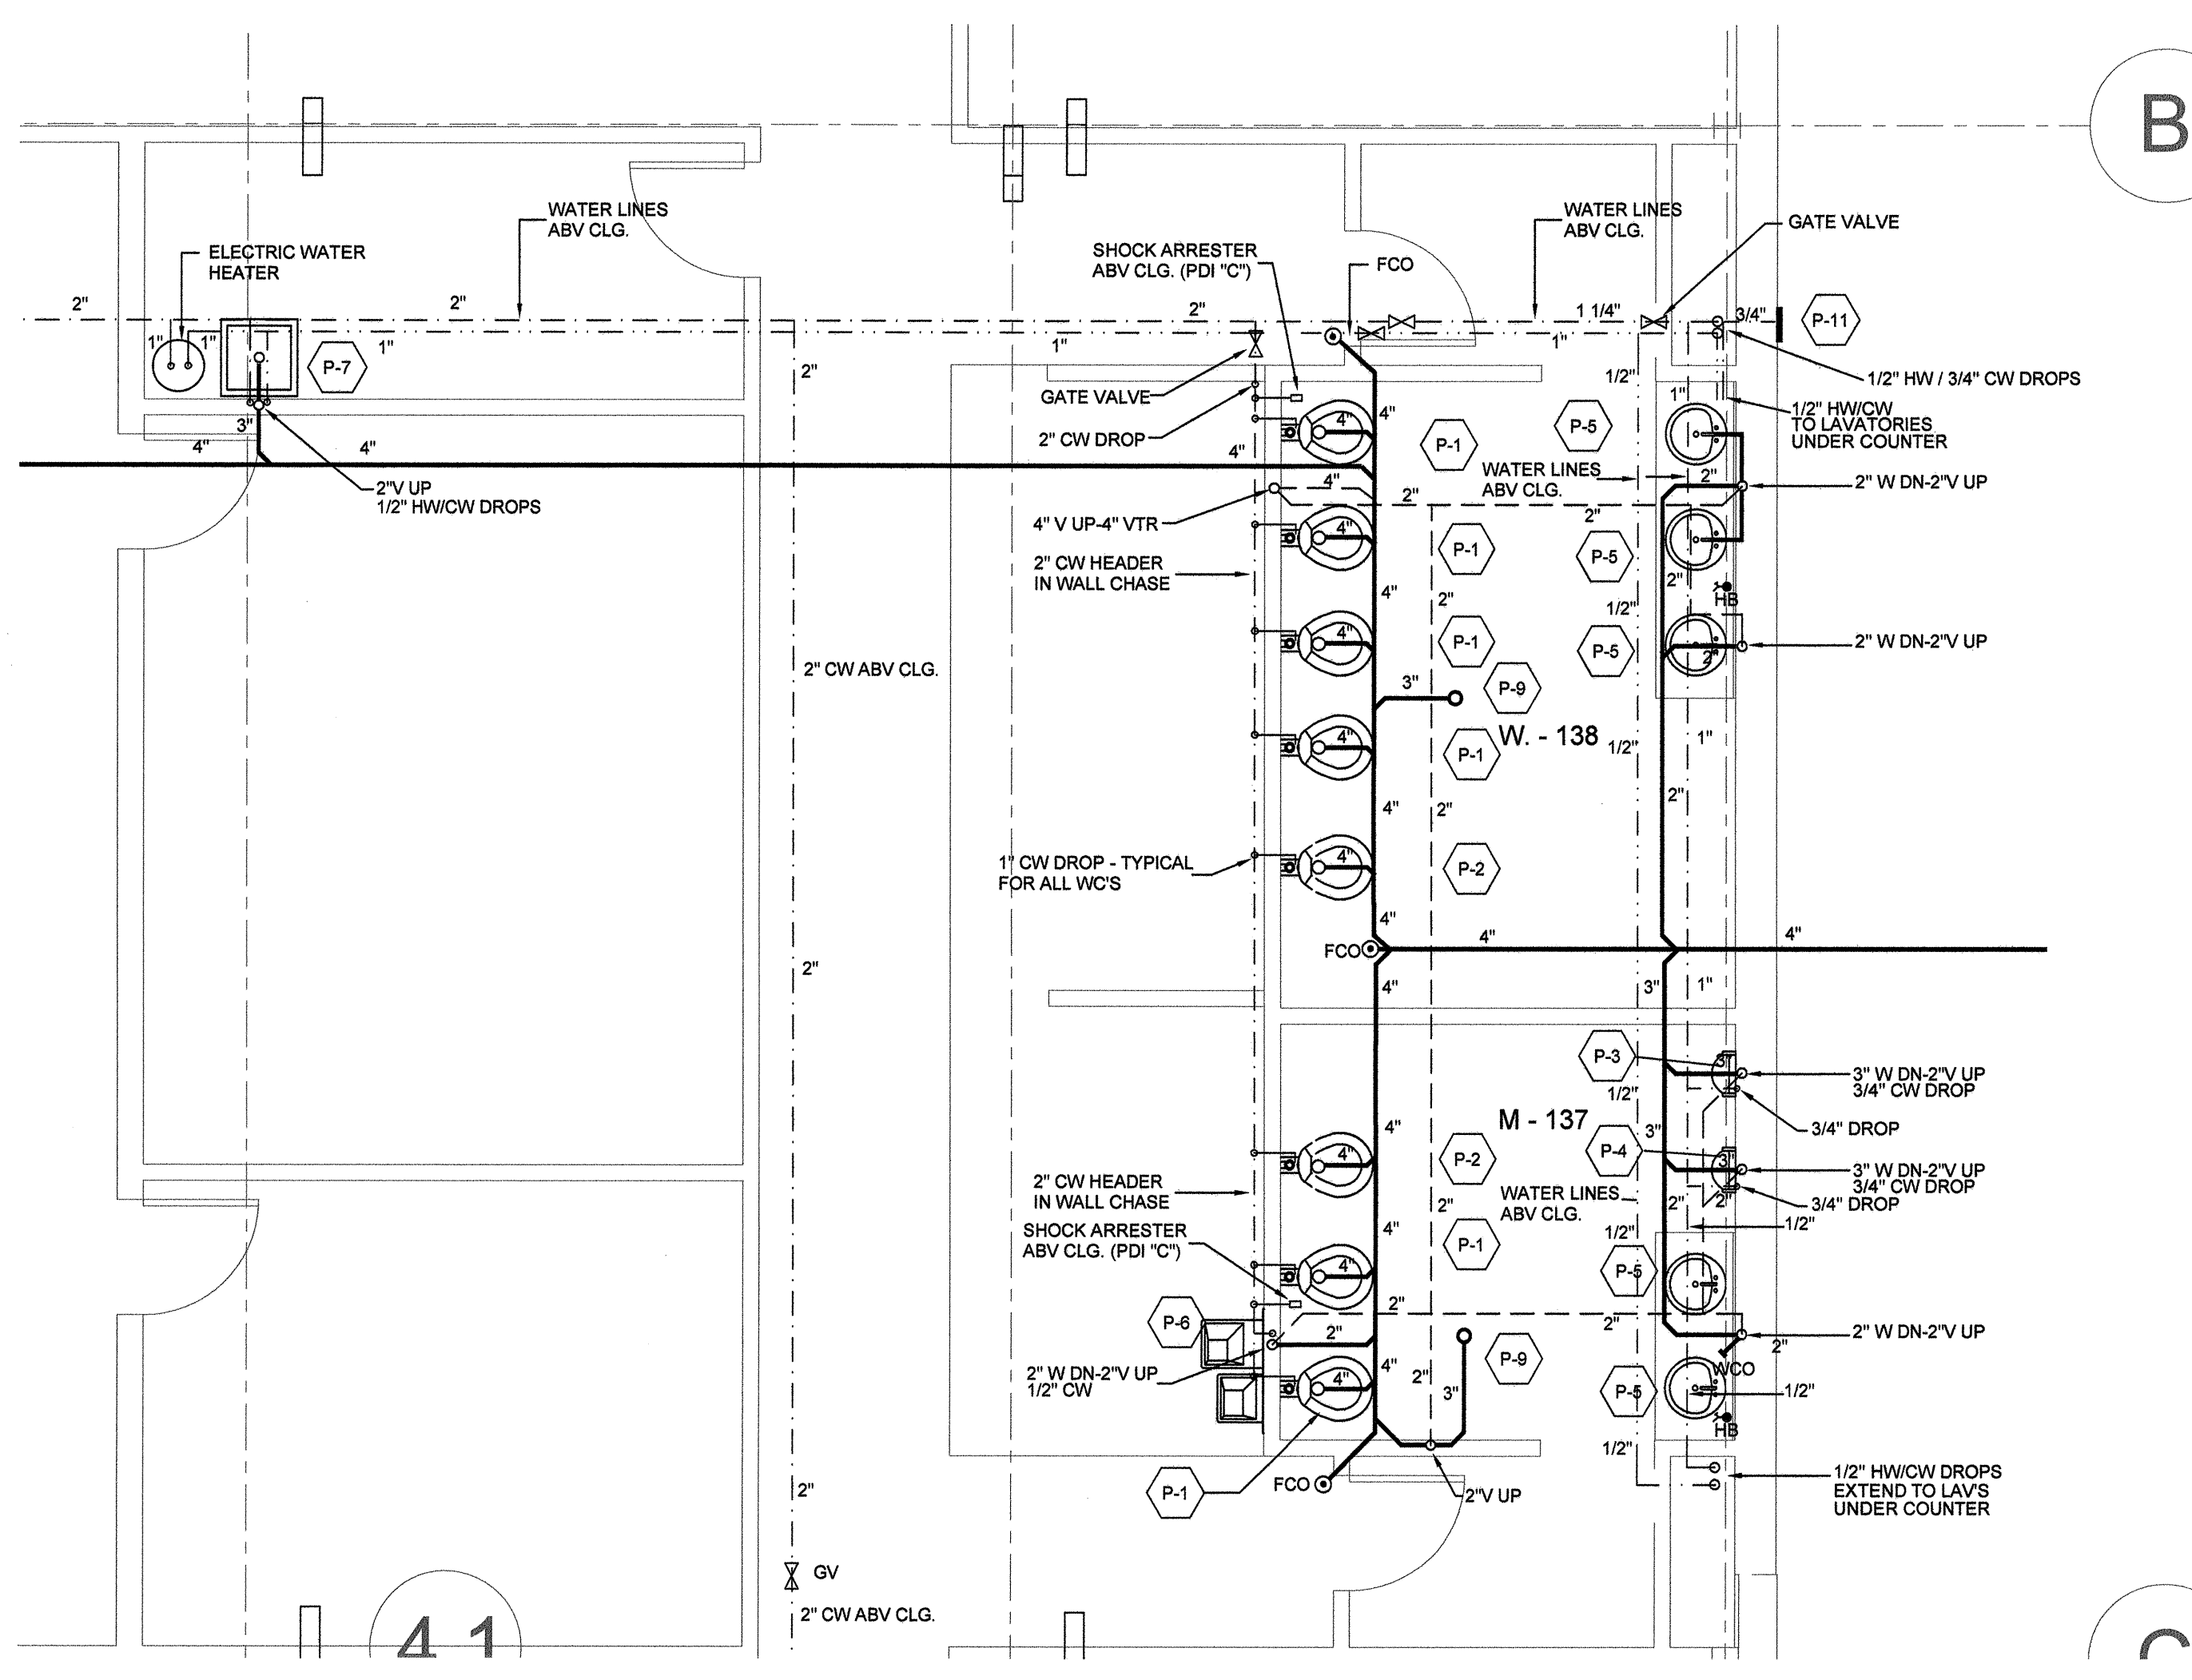


1 ENLARGED PLUMBING PLAN- TOILET 136 & 137
P-2 SCALE: 1/4" = 1'-0"

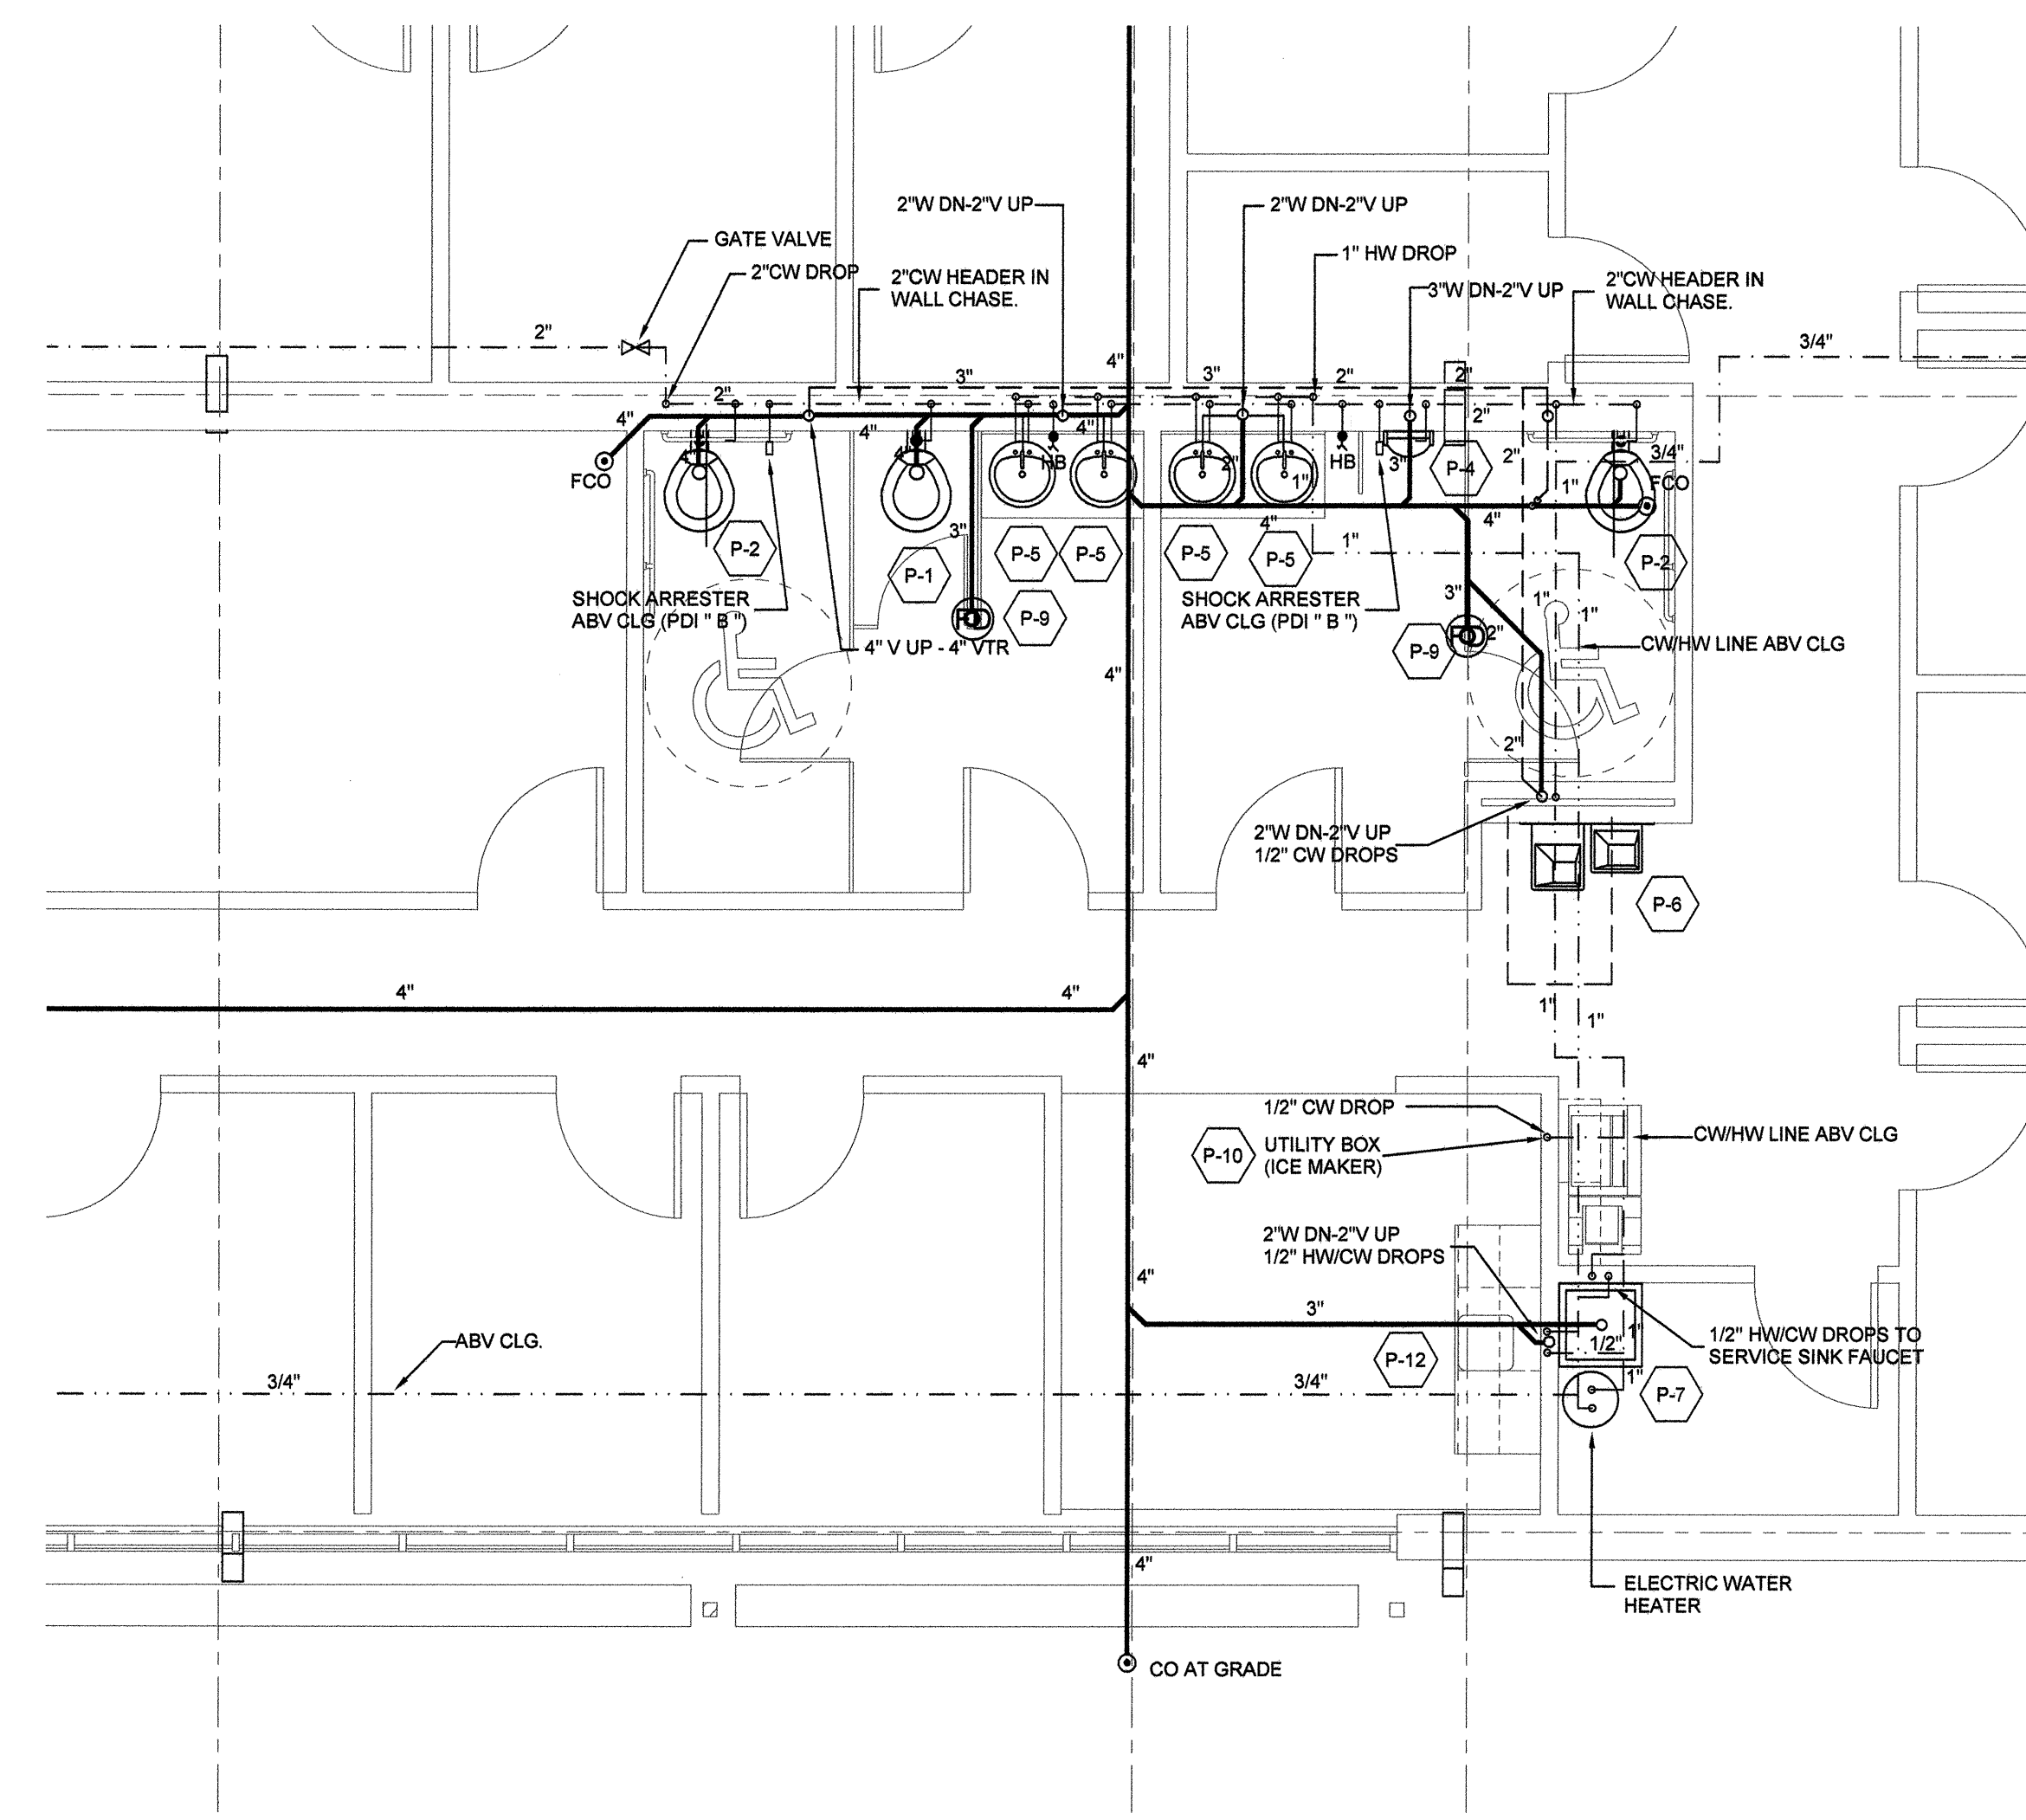


2 ENLARGED PLUMBING PLAN - TOILETS 118 & 119
P-2 SCALE: 1/4" = 1'-0"

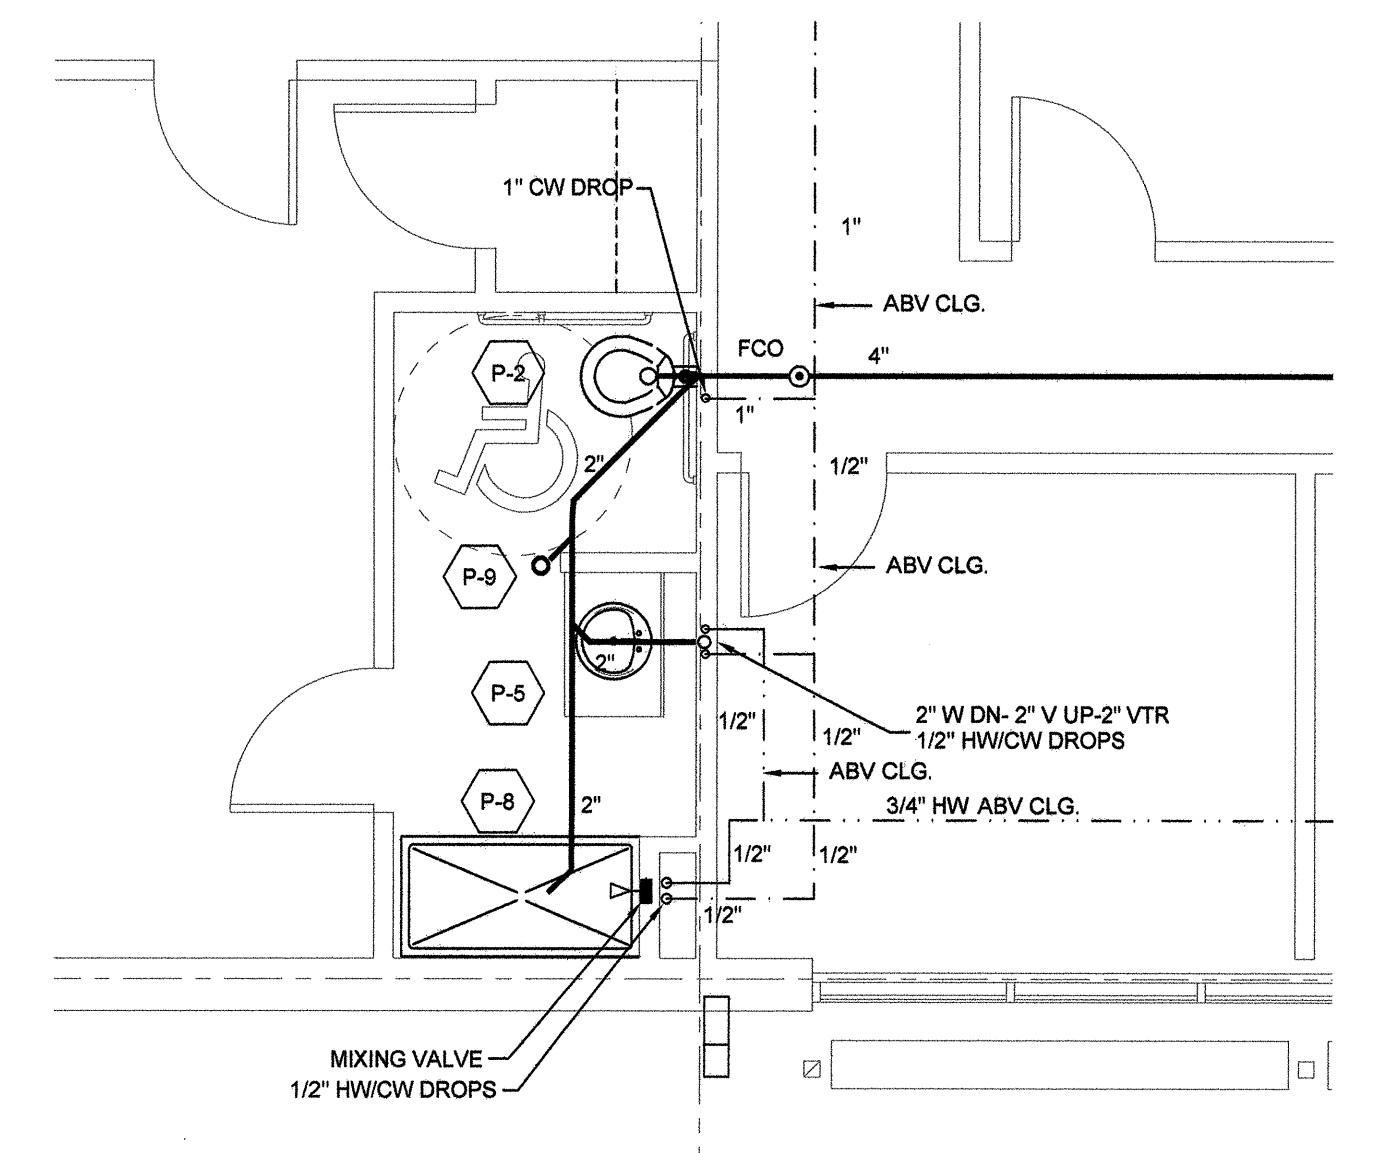


3 ENLARGED PLUMBING PLAN - TOILET 130
P-2 SCALE: 1/4" = 1'-0"

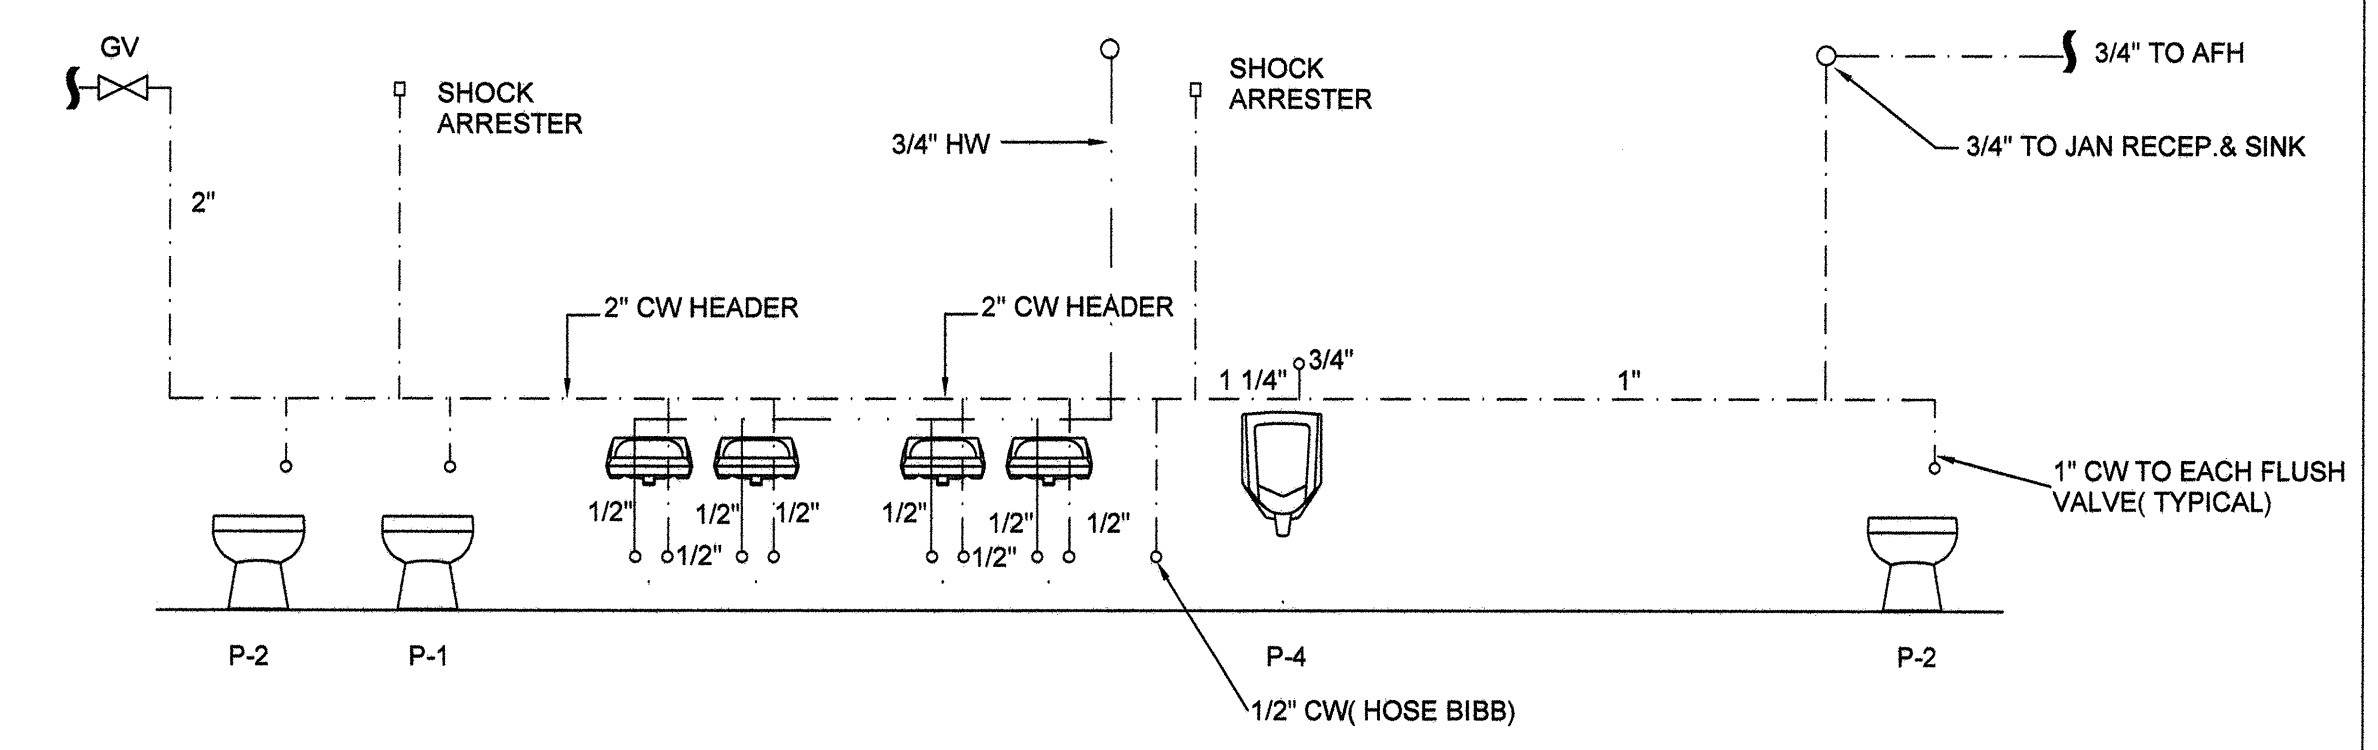


4 WATER RISER - TOILET 118 & 119
P-2 N.T.S.

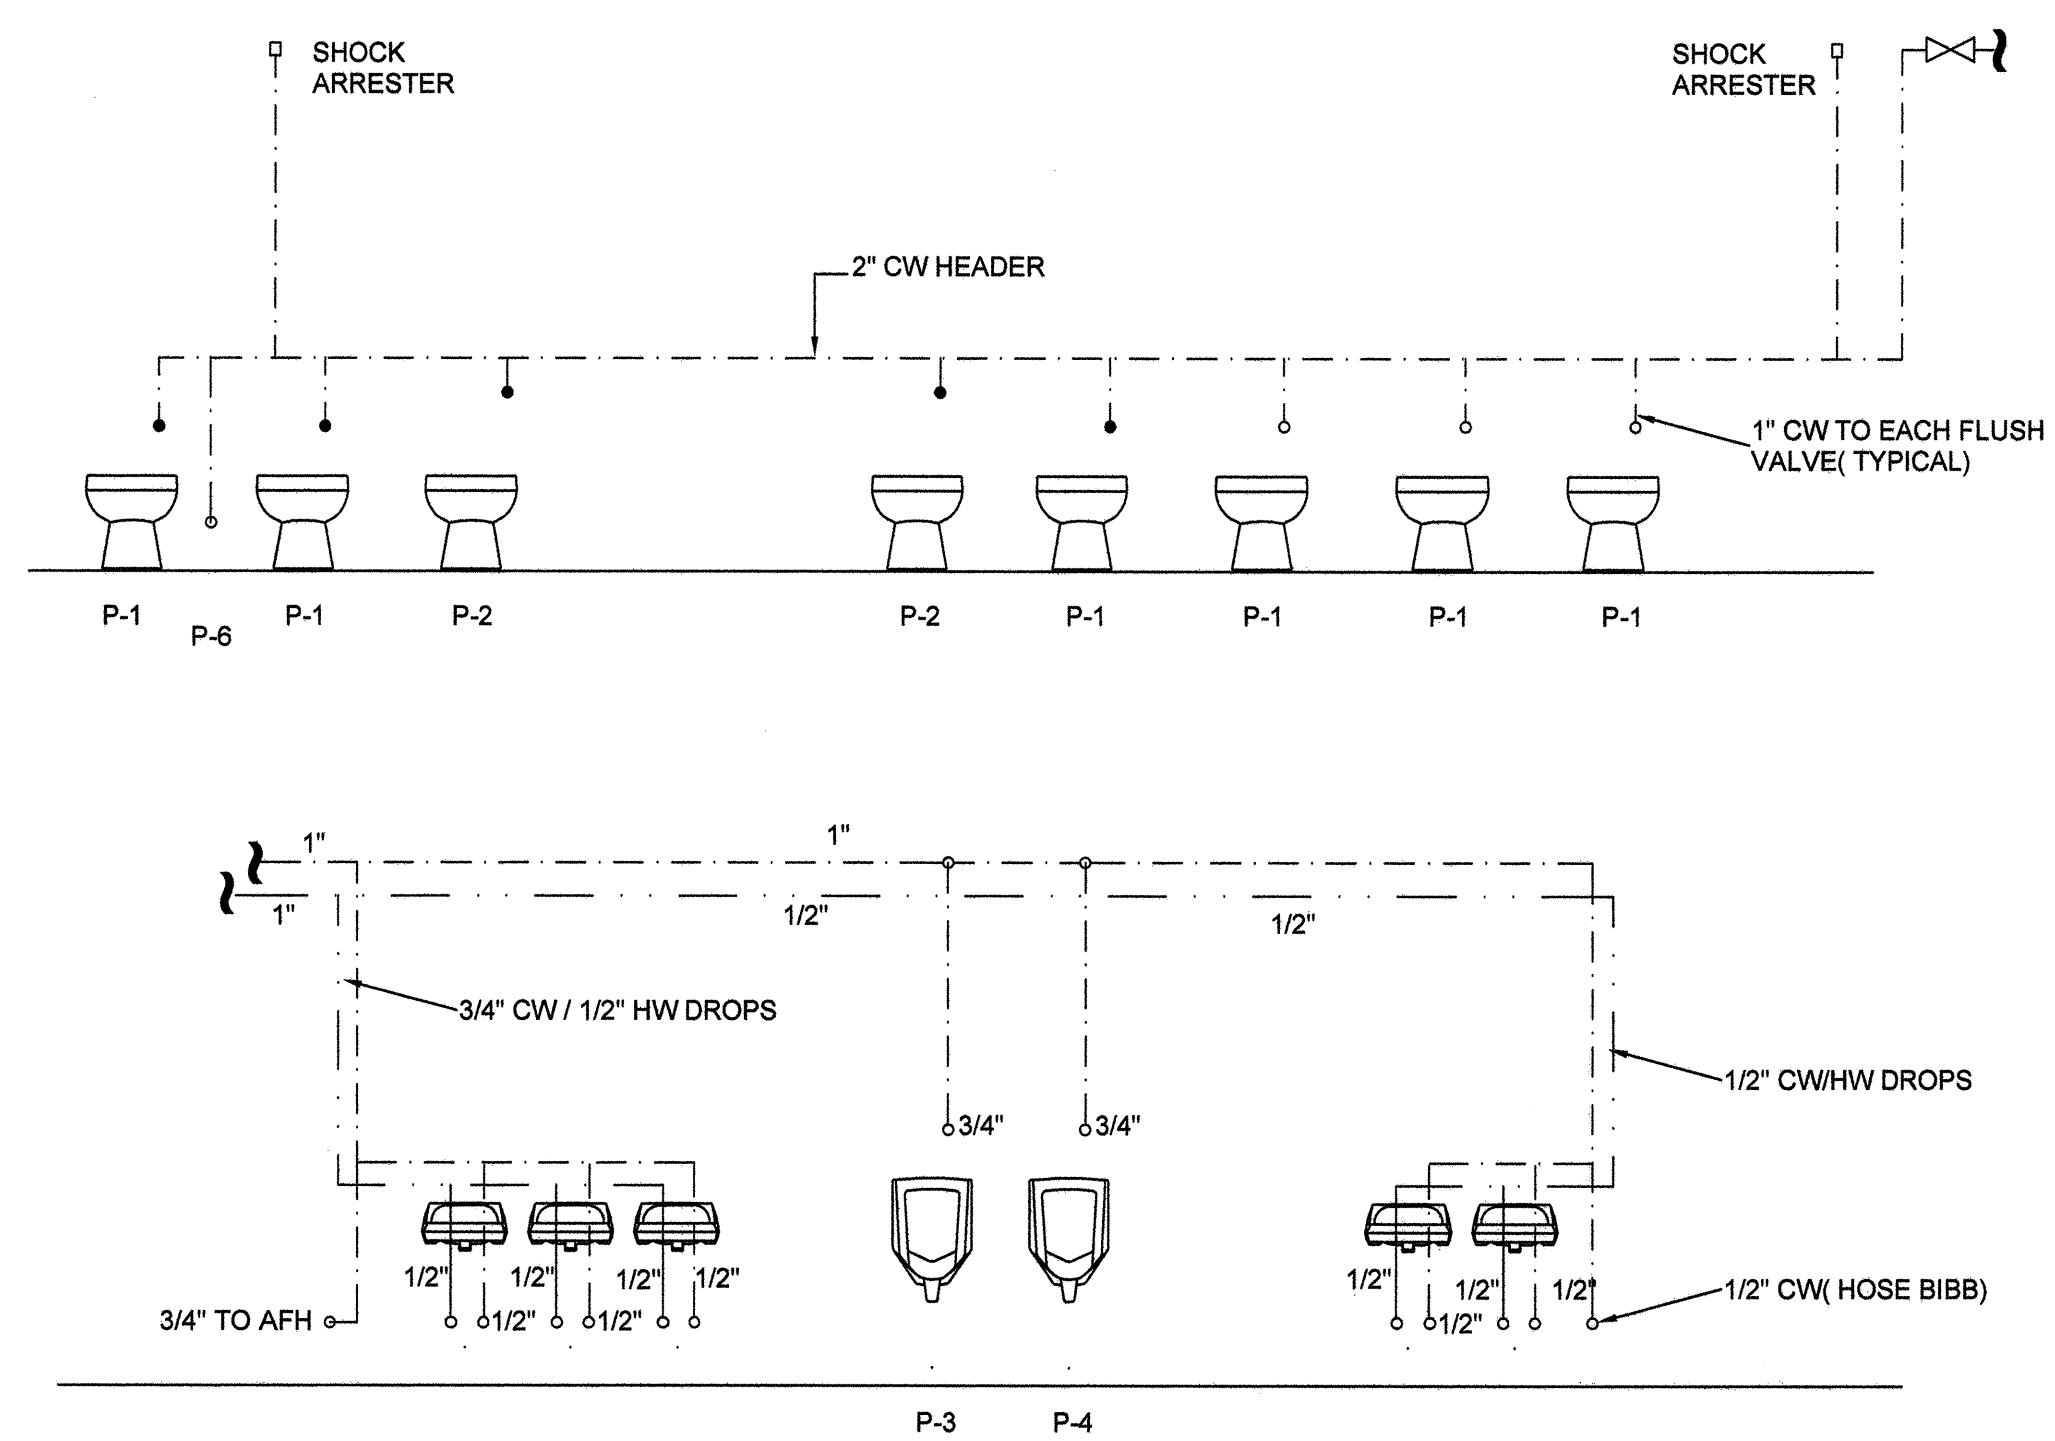

5 WATER RISER - TOILET 137 & 138
P-2 N.T.S.

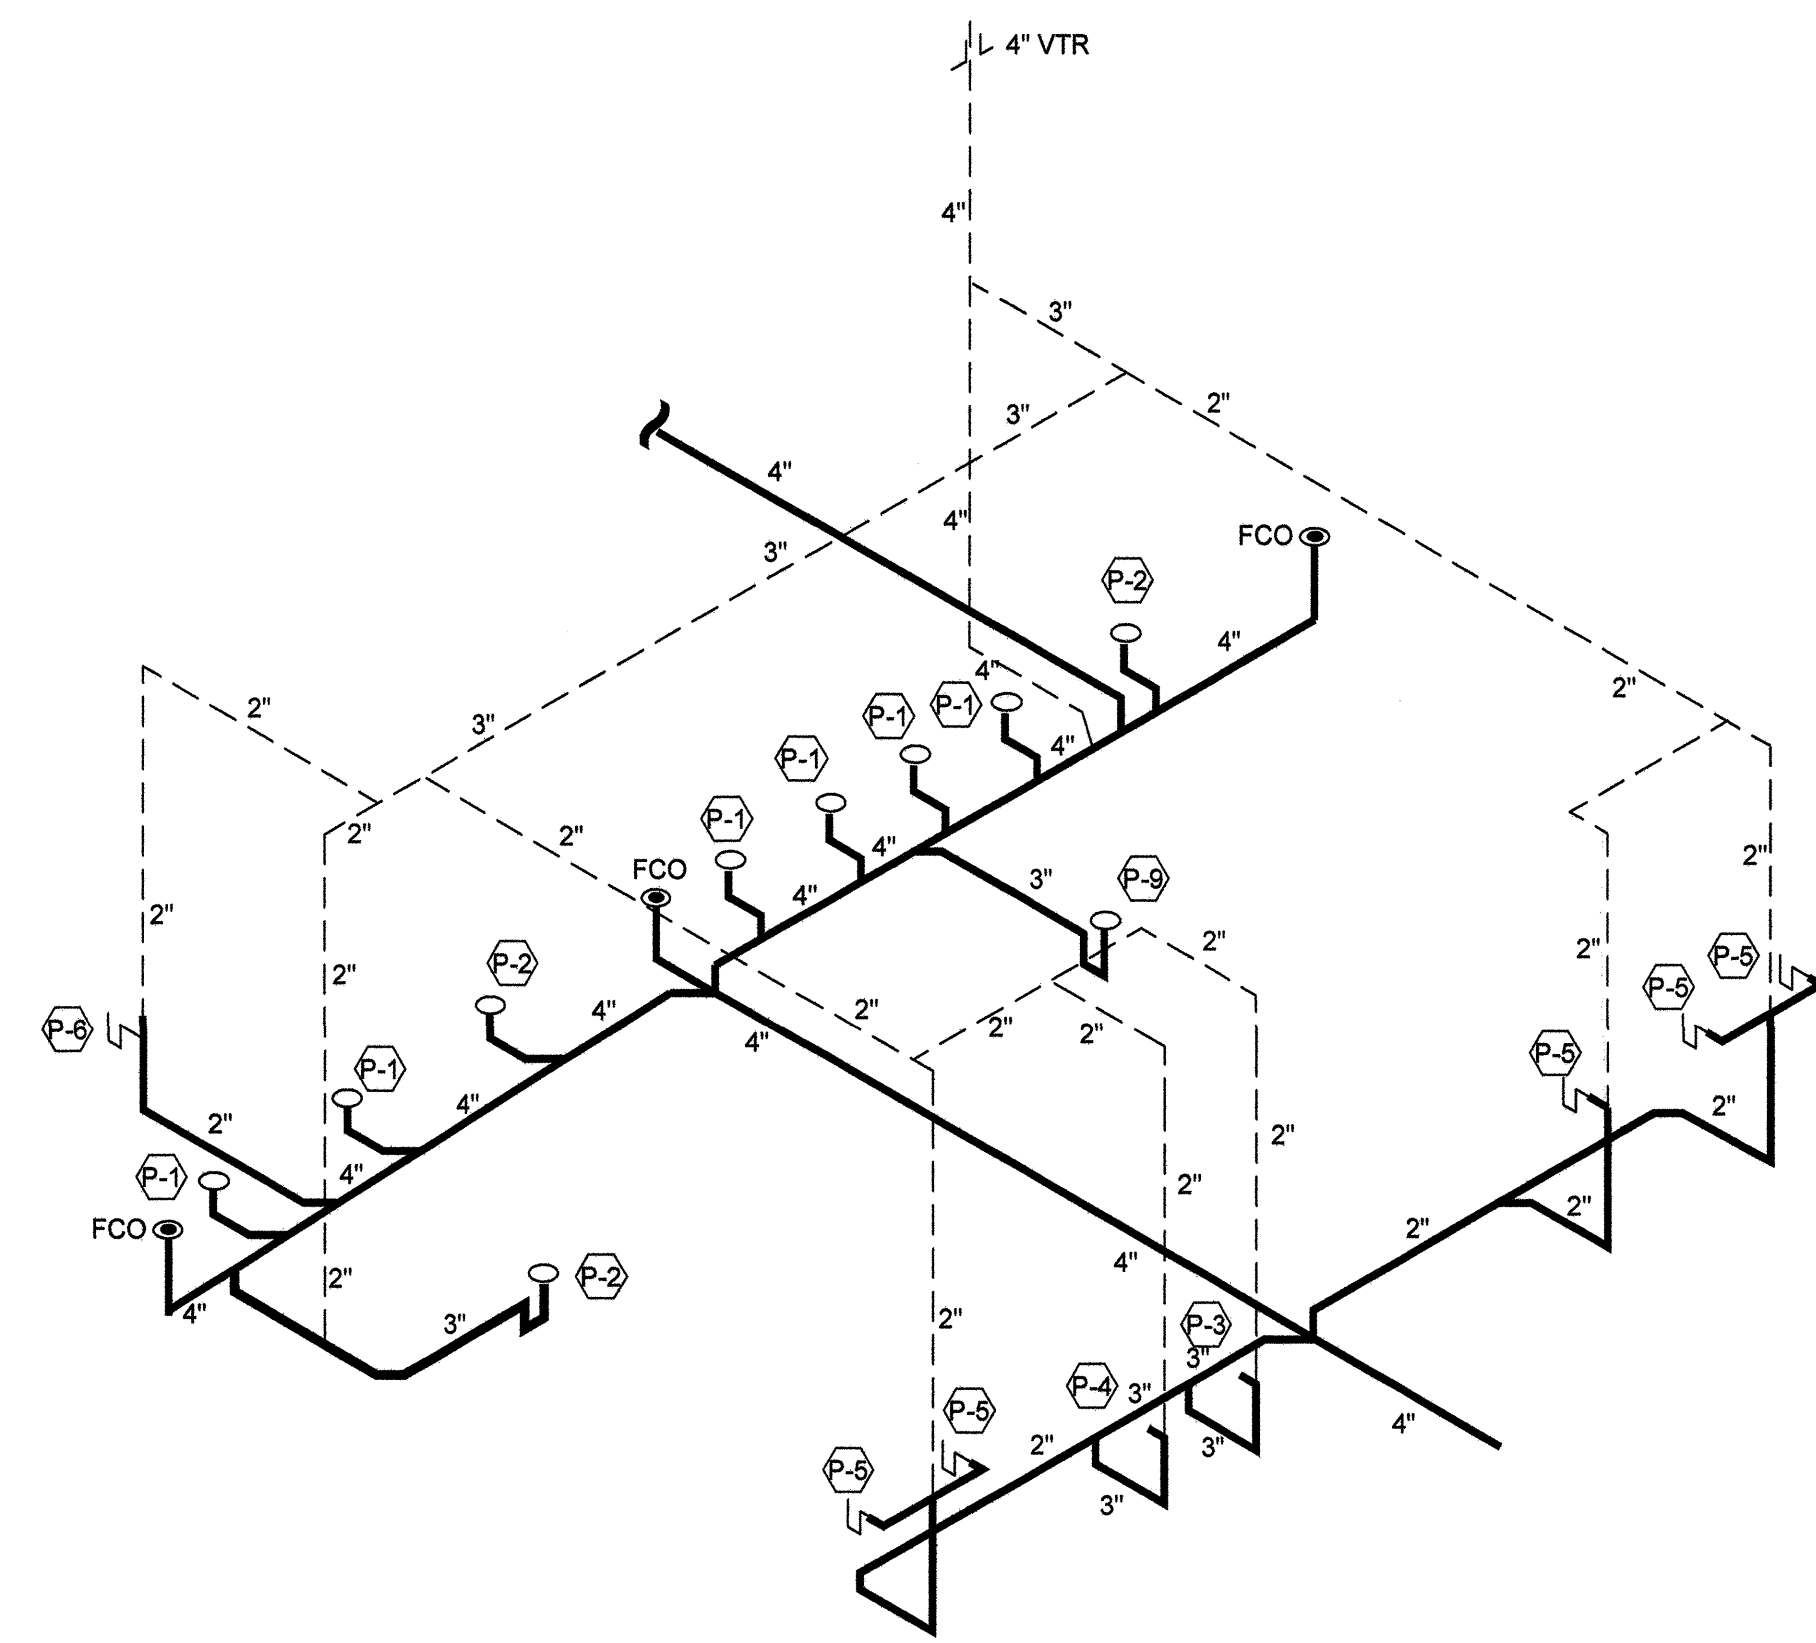

6 DWV RISER DIAGRAM - TOILET 137 & 138
P-2 N.T.S.

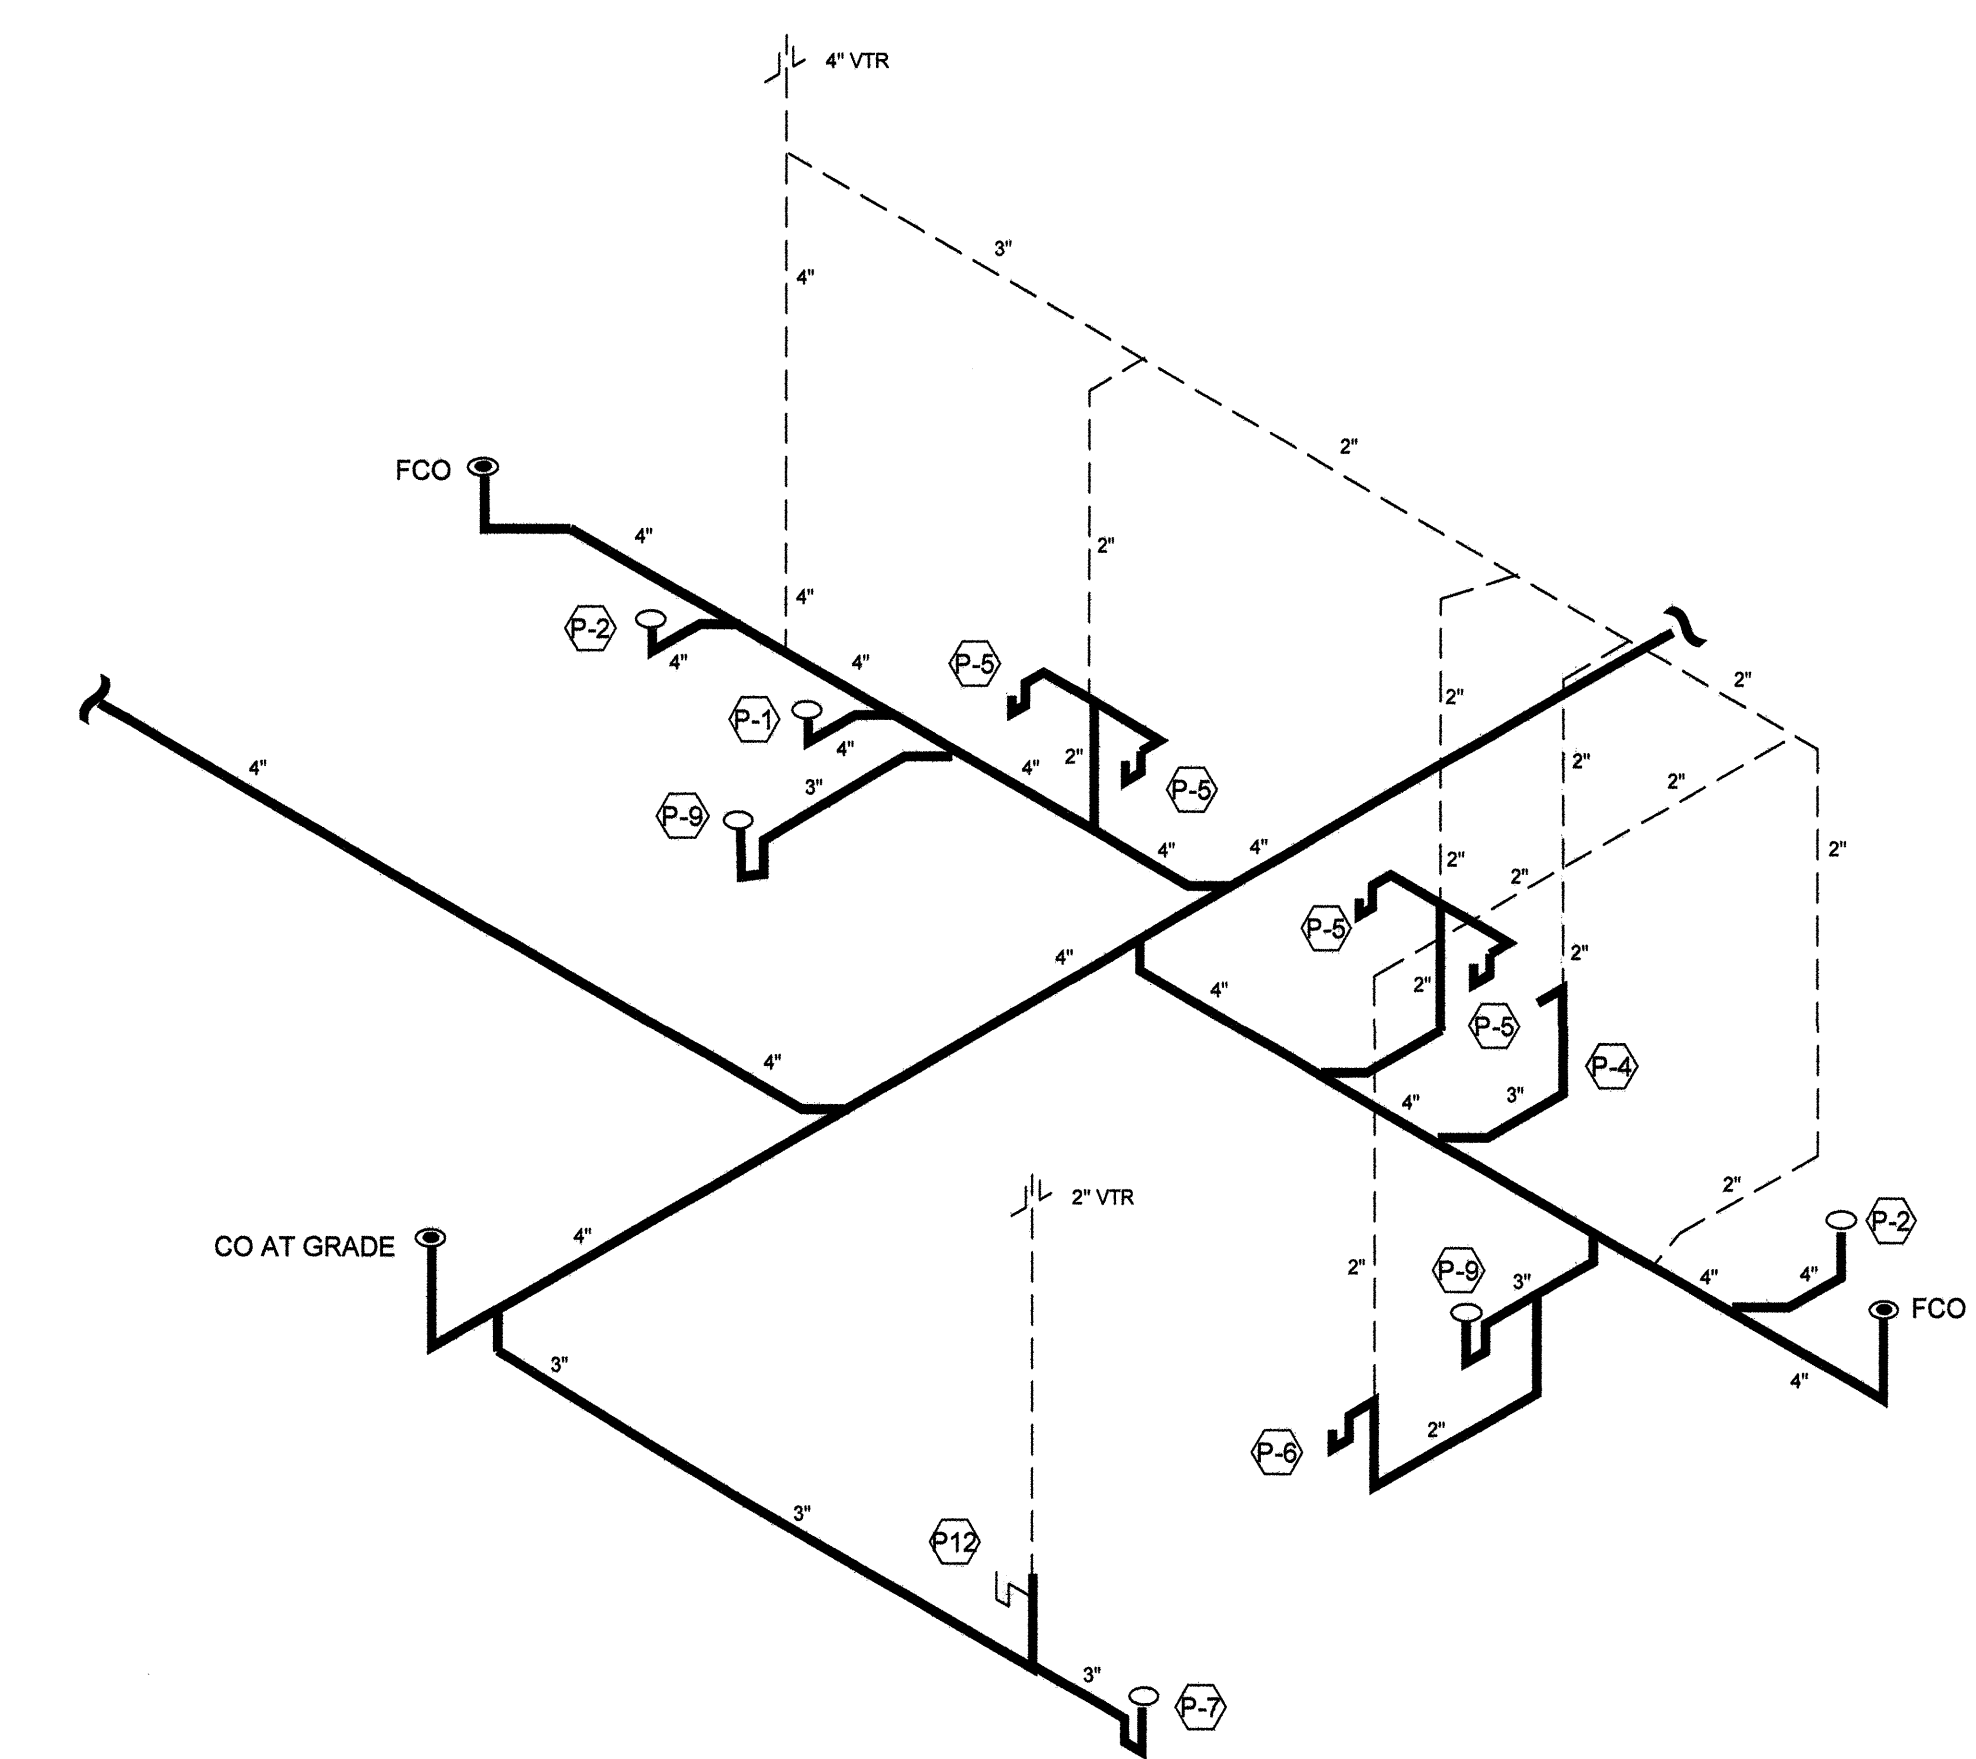

7 DWV RISER DIAGRAM - TOILET 118 & 119
P-2 N.T.S.